




WATER BOOSTER WB 299

TYPICAL WATER SUPPLY BOOSTER PUMP STATION DRAWINGS

EXAMPLE STREET, EXAMPLEVILLE

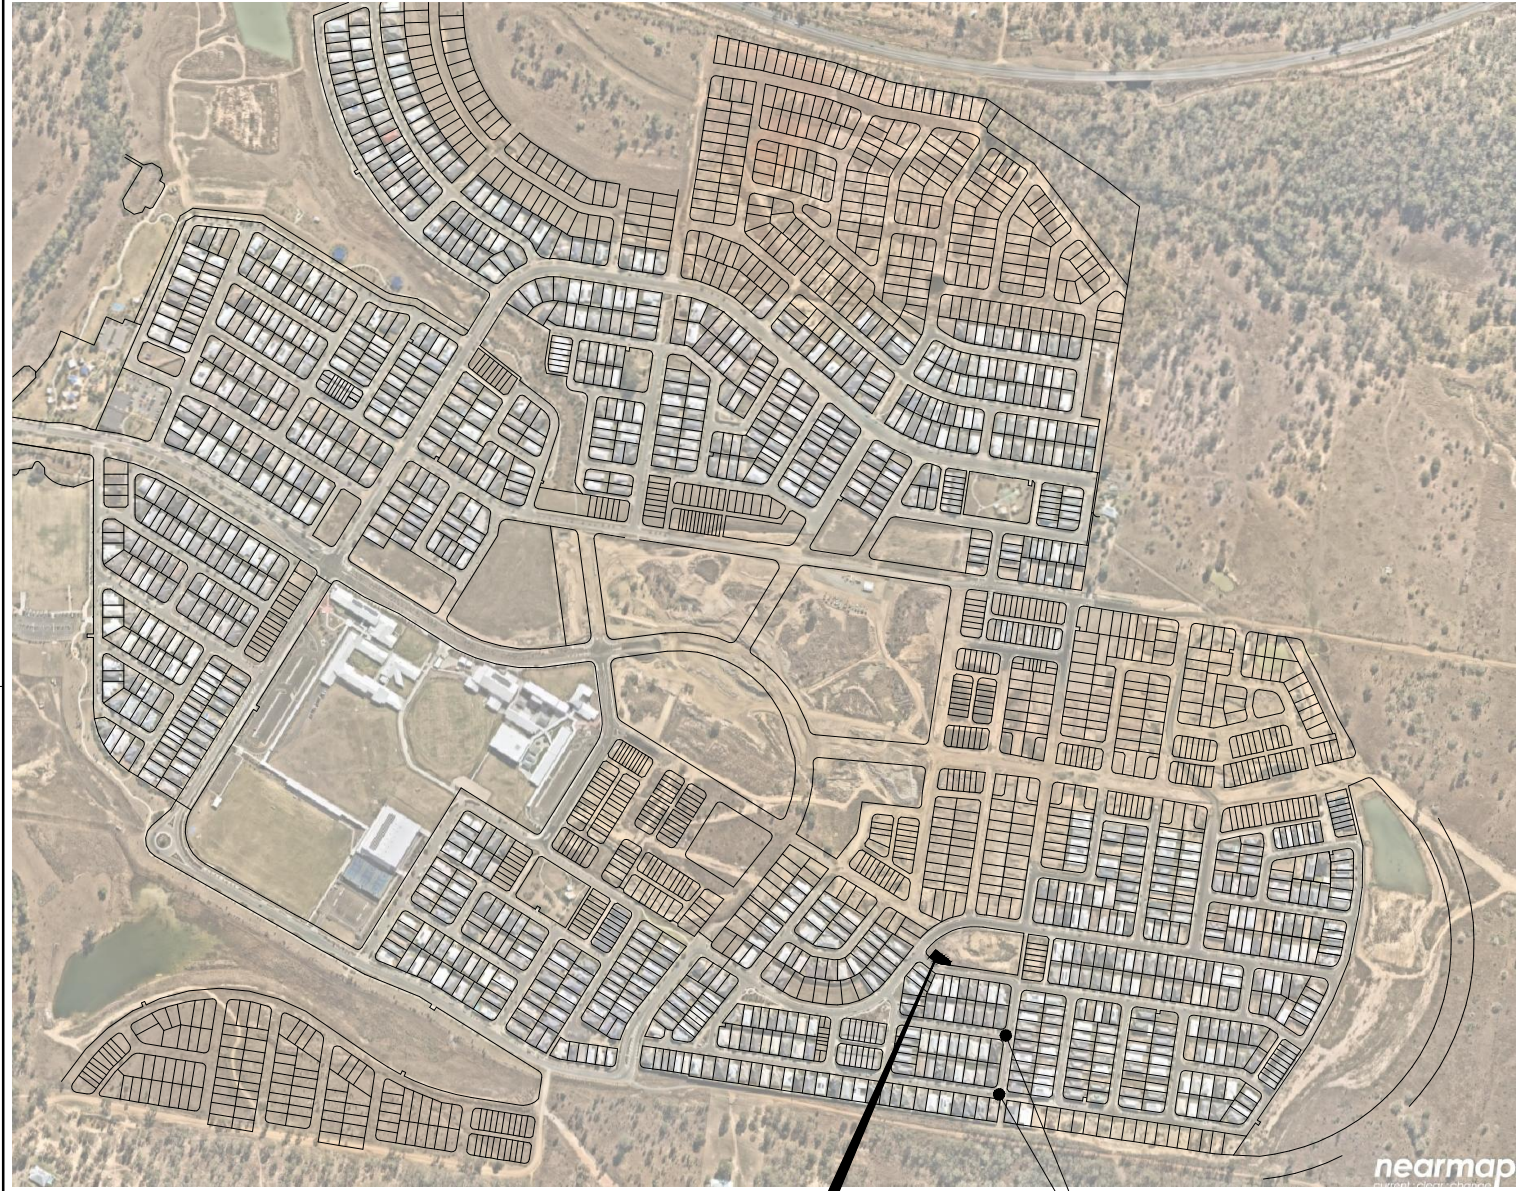

SITE OF WORK

HIGH LEVEL WATER ZONE - ISOLATION VALVES
ISOLATION VALVE TO BE LEFT IN OPEN POSITION UNTIL PUMP STATION COMES ONLINE

LOCALITY PLAN
N.T.S

DRAWING INDEX		
DWG No.	DESCRIPTION	REV
4310000001	TITLE PLAN, LOCALITY PLAN, DRAWING INDEX AND NOTES	0
4310000002	SITE PLAN, GENERAL ARRANGEMENT AND DRAINAGE PLAN	0
4310000003	BUILDING PLAN	0
4310000004	BUILDING ELEVATION	0
PROJECT SPECIFIC DRAWINGS SHOULD INCLUDE		
	COMMISSIONING PLAN	
	PUMP STATION ENTRANCE VEHICLE PATH	
	MATERIALS AND FINISHES SCHEDULE	
	PAVEMENT JOINT LAYOUT	
	CIVIL DETAILS	
	SOTRMWATER DRAINAGE LONG SECTION	
	PUMP STATION HIGH LEVEL ZONE (BOOSTED ZONE) LAYOUT	

 
No. OF LOTS = 1
AREA OF SITE = 0.035 ha

RP DESCRIPTION
LOT 35 ON SP123456
PARISH OF STANLEY

DATUM LEVEL
P.S.M PM123456
RL 65.564m AHD

CONSTRUCTION NOTE
DRAWINGS ARE TO BE READ IN CONJUNCTION WITH ALL OTHER SPECIFICATION DETAILS

CONSTRUCTION HOLD POINT
PRIOR TO CONSTRUCTION THE CONTRACTOR SHALL RE-CONFIRM LEVELS OF ALL EXISTING CROSSINGS AND CONNECTION POINTS.



FOR INFORMATION

REV.	DATE	AMENDMENT	DRAFTED	APPROVED	UU CAD FILE	413000001.dwg	UU FILE REFERENCE



URBAN UTILITIES DELEGATE _____ DATE _____

ASSET/PROJECT
TYPICAL WATER SUPPLY BOOSTER PUMP STATION

DRAWING TITLE
TYPICAL COVER SHEET AND LOCALITY PLAN

SHEET No. 1 OF 5	
URBAN UTILITIES DRAWING No. 413000001	REVISION A
DRAWING STATUS CONCEPT	

G:\104 WATER SUPPLY\208 Drafting\248 Plans\Standards\Drawings\QIU Standards\Water\Water Booster\Develop\413000001.dwg - P:Printed by 082892 on 2020.09.07 at 11:16